


ELECTRICAL PLAN
SCALE: 1/4" = 1'-0"

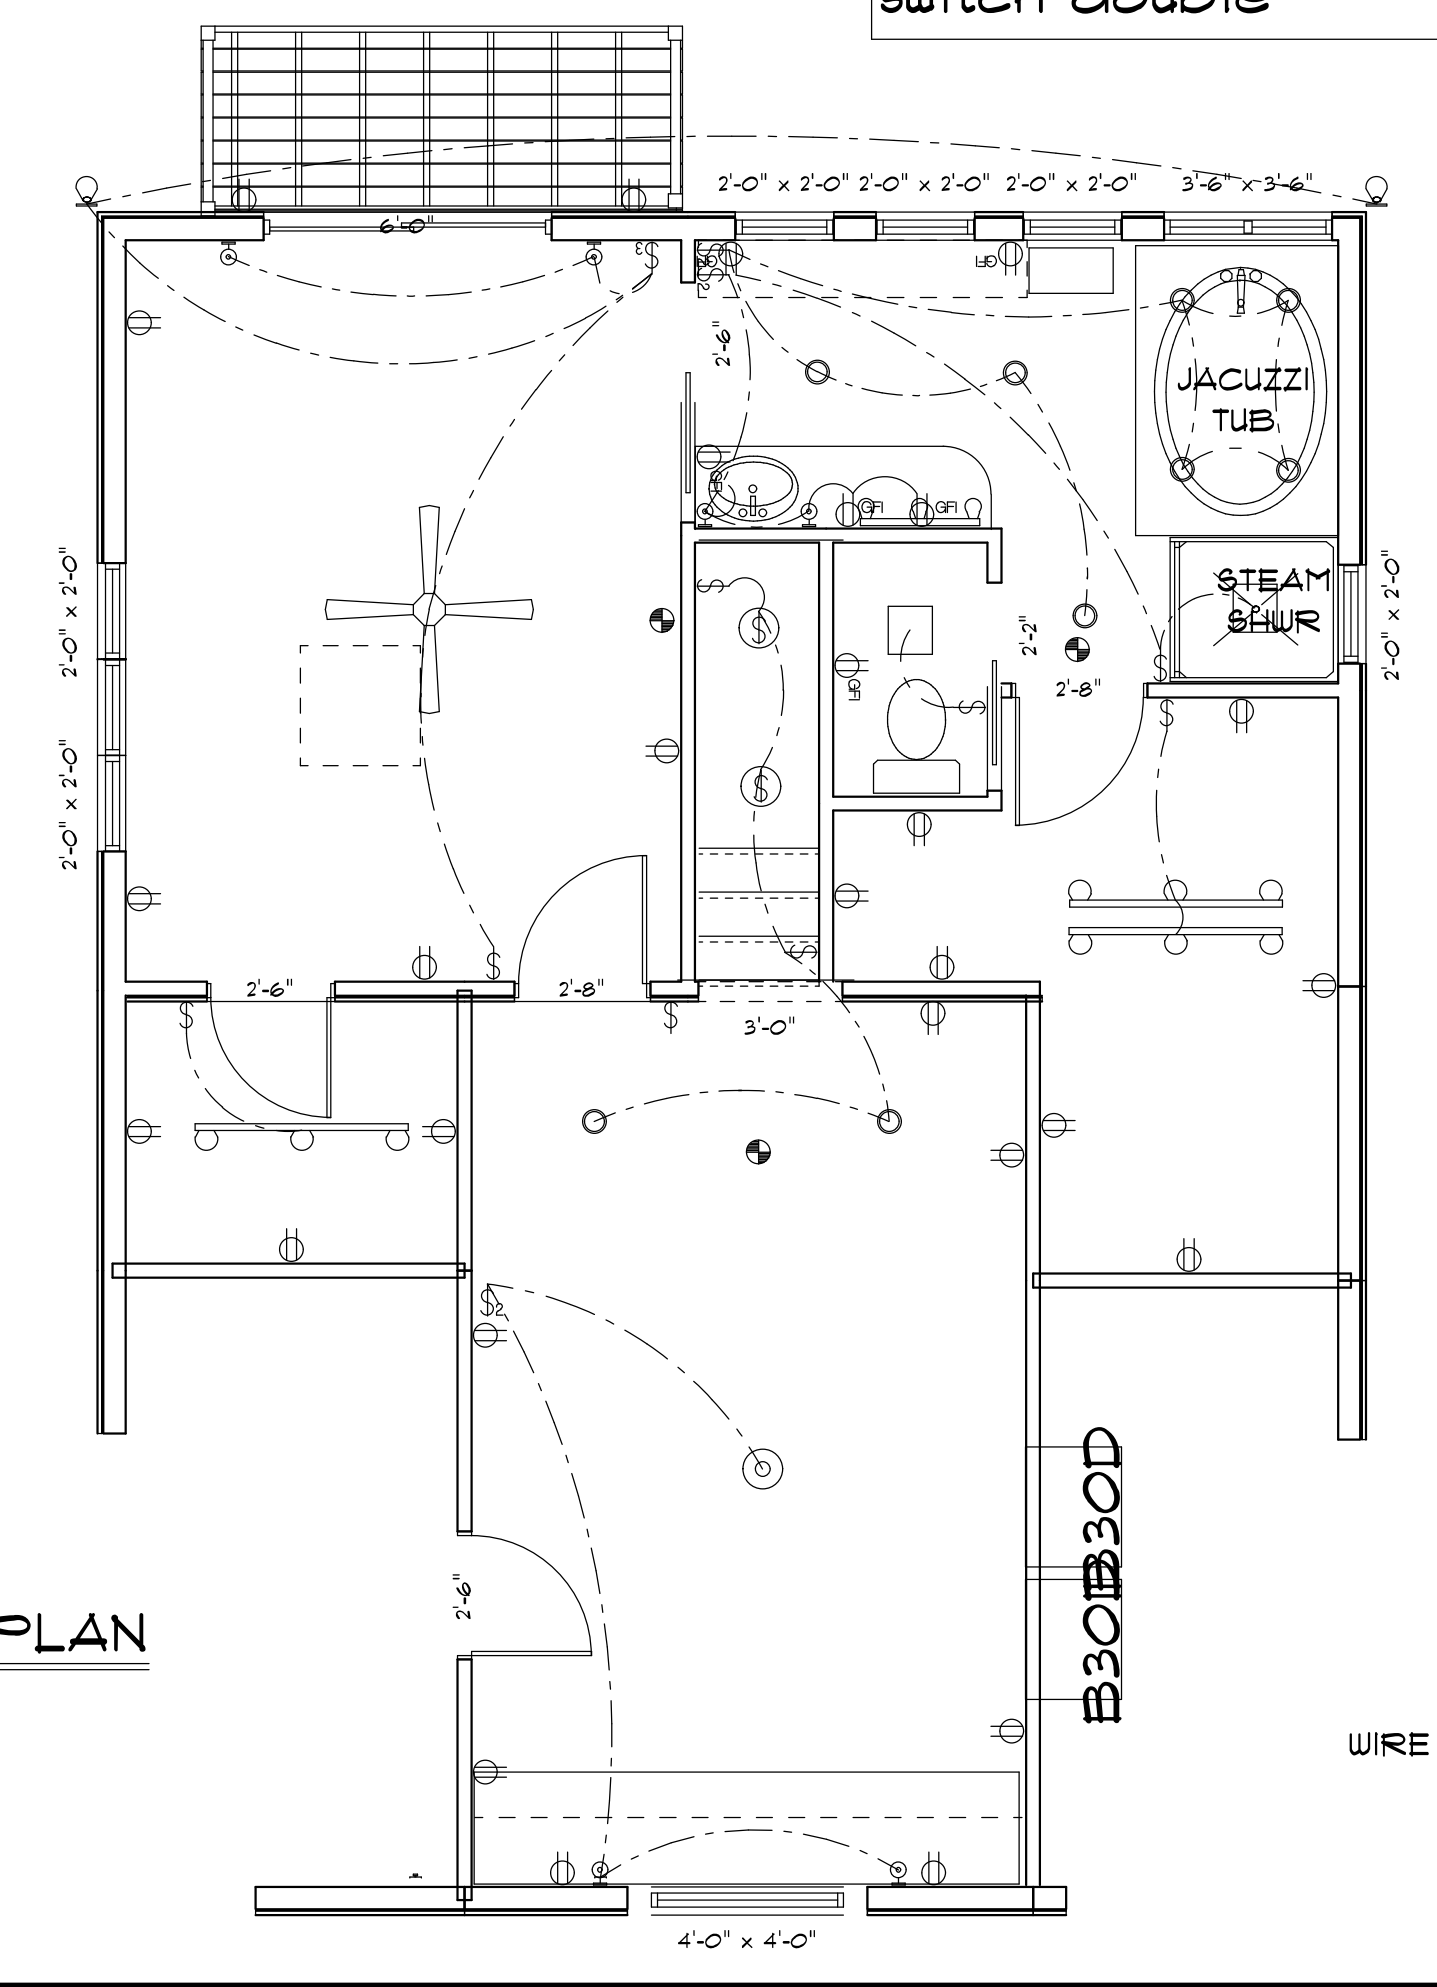

WIRE FOR SOUND, COMPUTERS, AND CABLE
PER OWNER'S SPEC

ELECTRICAL	COUNT	SYMBOL
ceiling fan	1	
ceiling light vent square	2	
ceiling pull switch	2	
ceiling shade square	1	
ceiling globe light	1	
pot light	9	
single spotlight	2	
track light	4	
wall mount 2	3	
wall sconce	6	
dimmer switch	1	
electrical panel	1	
telephone jack	1	
outlet	23	
outlet gfi	6	
smoke detector	3	
switch	10	
switch 3 way	1	
switch double	3	